


Exit

Exit

Yellow indicates area of dropped ceiling grid

LIGHT FIXTURE SCHEDULE			
	Surface Mount, 6" X 48" Led, RAB Lighting, Model GUS17-4-50W-3500K or Equal	Surface	60 ea
	Drop In, 24" X 48" Led, RAB Lighting Model T34FA-2X4 or equal <i>Frame for some surface mount SMK PANEL2X4</i>	Recessed	10 ea
	Recessed, 6" diameter LED RAB Lighting Model CR6-17W-3500K or equal	Recessed	26 ea
	Surface, 6" diameter LED RAB Lighting Model DSKR229FA120WS or equal	Surface	24 ea
	Suspended, 8" LED - Lobby Light Suspended RAB Lighting Model TOMO-8-96w-3500K or equal	Suspend	8 ea
	Emergency Egress LED fixture and emergency light - RAB Lighting Model ECOMBO34-R with optional directional arrows or equal	Surface	14 ea

# Healing Hands Health Center

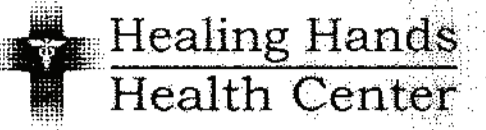

Midway Medical Park  
Bristol, TN 37620  
Phone: 423-646-4982


Renovation for:  
**225 Midway Medical Park**  
Bristol, Tennessee

FLOOR PLAN

NO.	DATE	BY
1		

DATE: 3-18-2023  
DRAWN BY: G. McGeough  
CHECKED BY:  
PROJECT N°:

DRAWING N°: **A105**

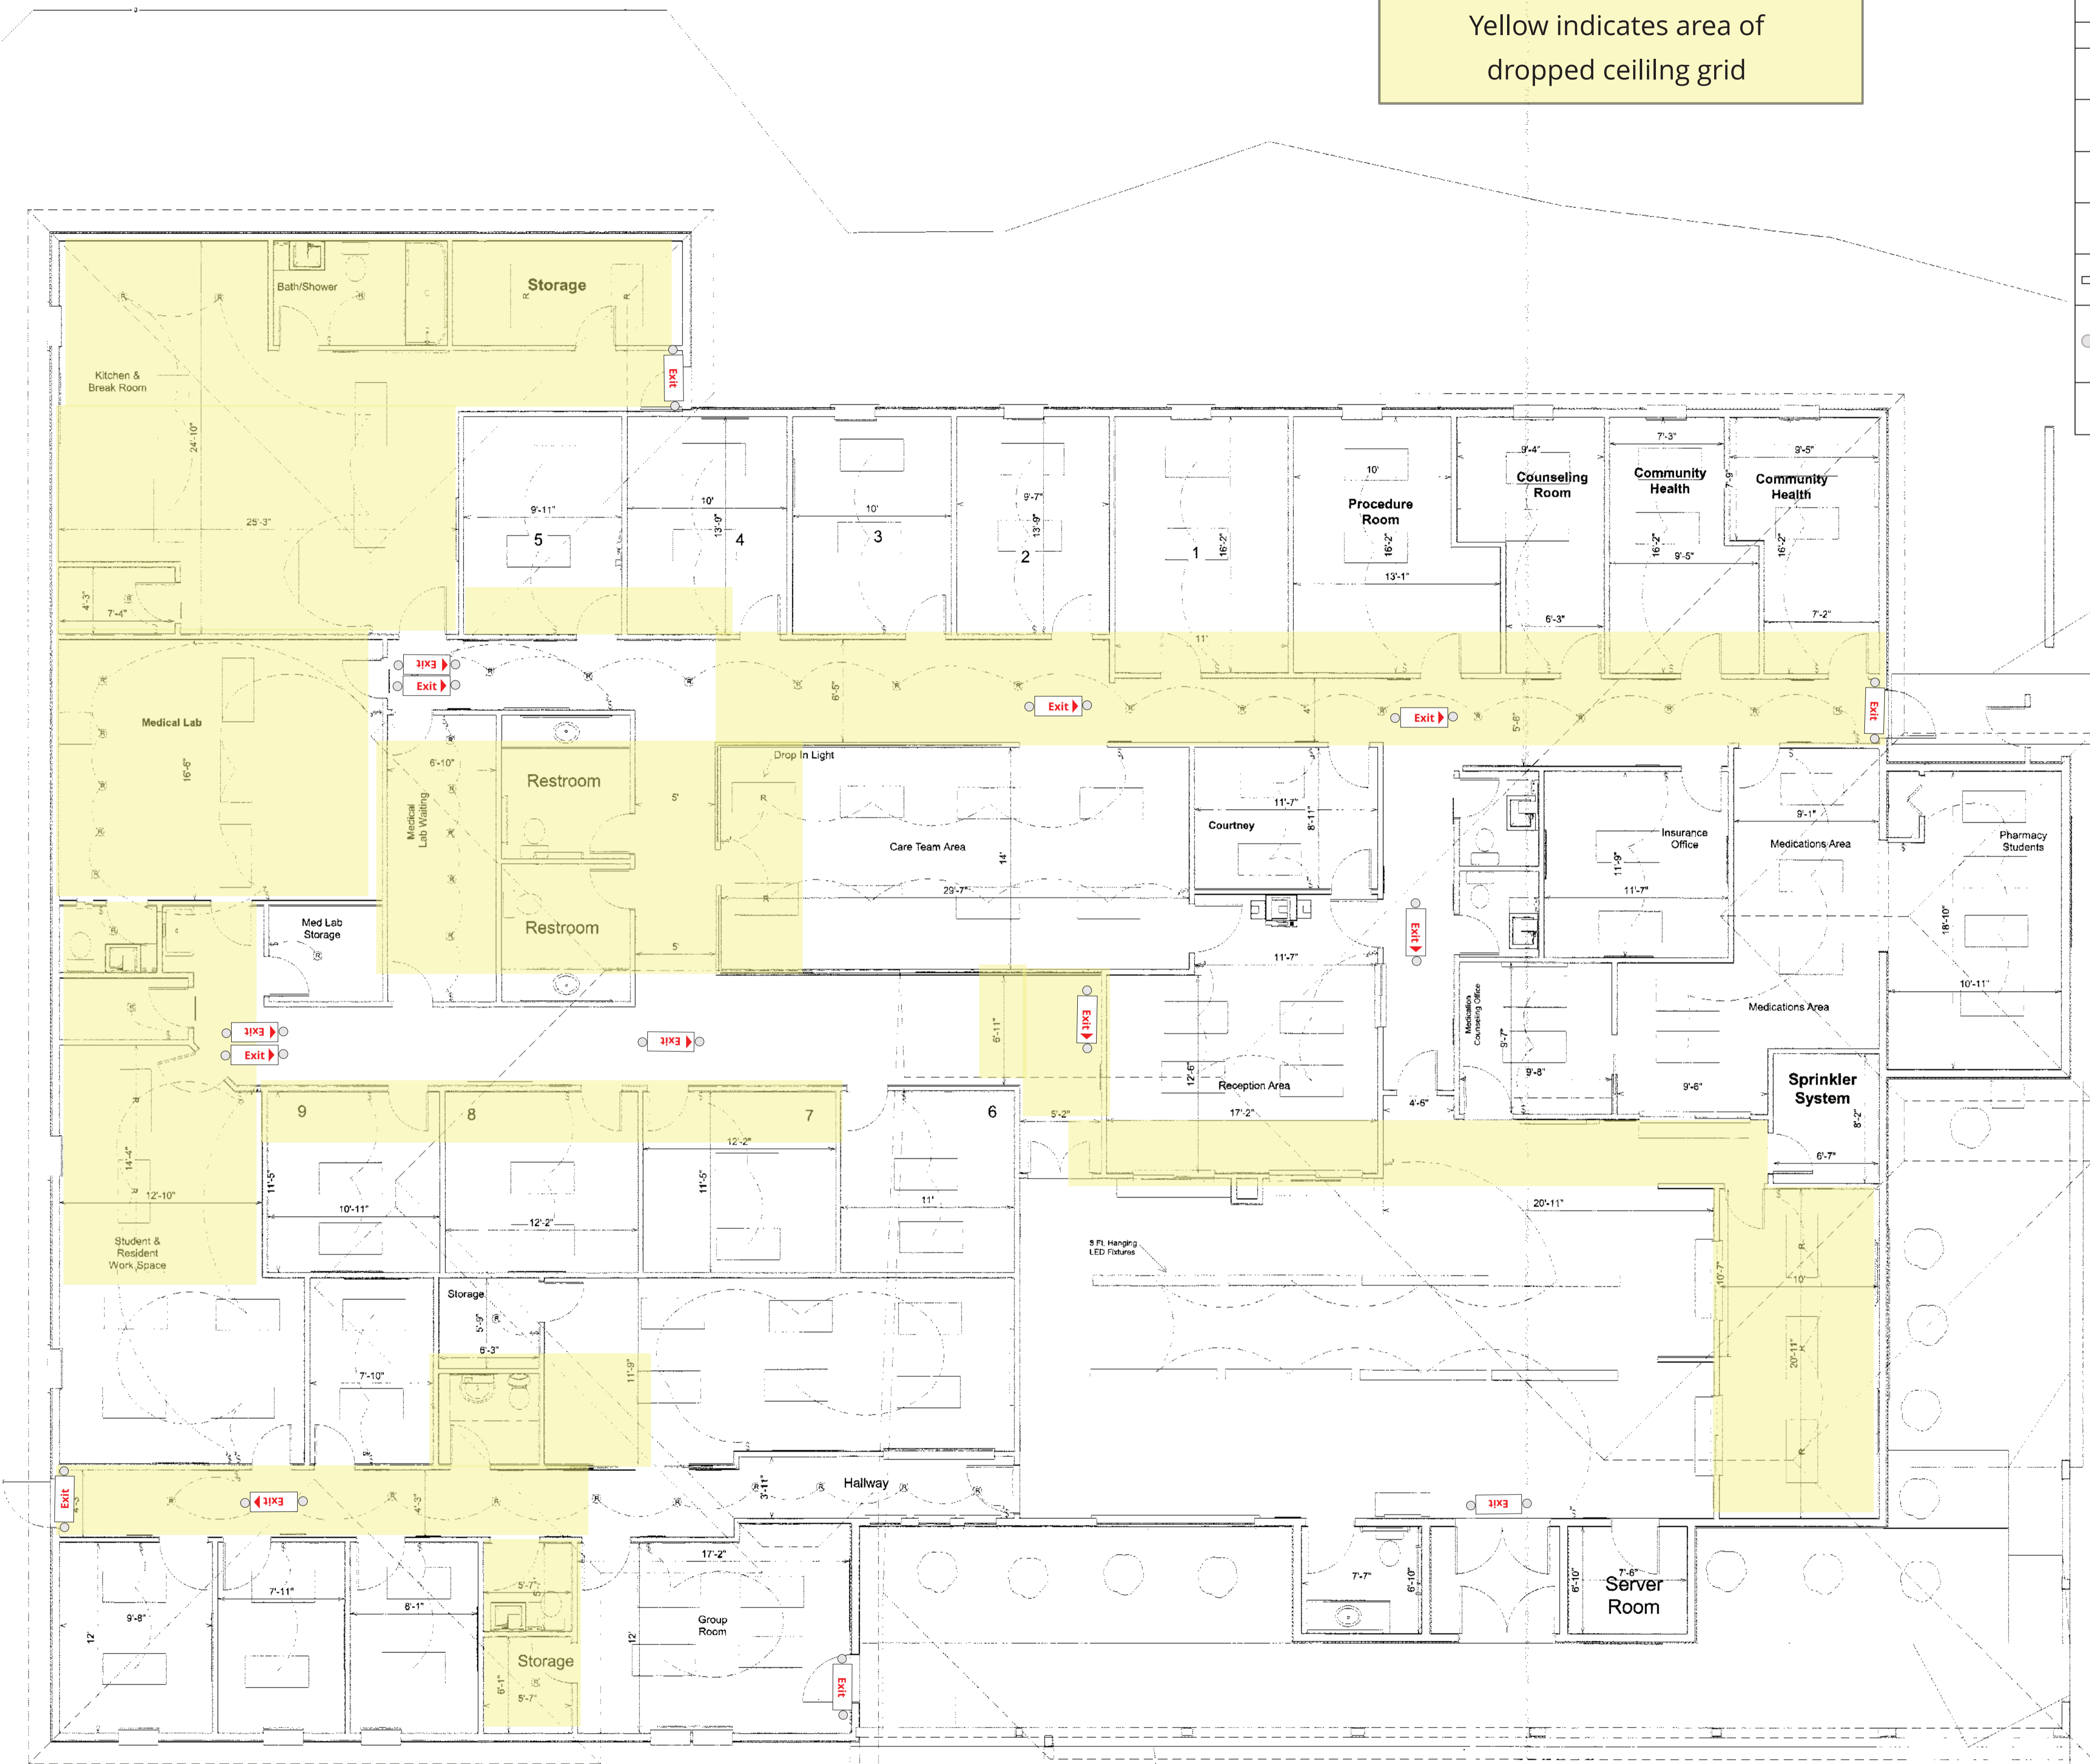

Parking Lot

## Lighting Plan Ang. 8, 2024